

इपिडिमियोलोजी तथा रोग नियन्त्रण महाशाखाको आ.ब.०७७/७८ स्वीकृत बार्षिक
कार्यक्रममा समावेश वित्तिय हस्तान्तरण मार्फत स्थानीय तहमा पठाइएको हेल्थ
डेस्क भवन निर्माणको नक्शा डिजाइन



नेपाल सरकार
स्वास्थ्य तथा जनसंख्या मन्त्रालय
स्वास्थ्य सेवा विभाग
इपिडिमियोलोजी तथा रोग नियन्त्रण महाशाखा
टेकु, काठमाडौं



 

नेपाल सरकार
स्वास्थ्य तथा जनसंख्या मन्त्रालय
स्वास्थ्य सेवा विभाग
टेकु, काठमाडौं

ARCHITECTURAL DRAWINGS

- 01: Proposed Ground Floor - Furniture Detail
- 02: Proposed Truss Layout
- 03: Proposed Elevations
- 04: Proposed Elevation & Sections
- 05: Proposed Opening Schedule



Ministry of Health & Population
RAMSHAHPATH, KATHMANDU



Nepal Health
Sector Support
Program

Health Building Infrastructure
Standard Design Drawings



Drawing Title

Table of Content

Sheet no.

 
AR/00
00

- 01: Proposed Ground Floor - Furniture Detail
- 02: Proposed Truss Layout
- 03: Proposed Elevations
- 04: Proposed Elevation & Sections
- 05: Proposed Opening Schedule



Ministry of Health & Population
BAMSHAHIPATH, KATHMANDU

[Handwritten signature]
स्वास्थ्य सेवा विभाग



Nepal Health
Sector Support
Program

Health Building Infrastructure
Standard Design Drawings

[Handwritten signature]




Drawing Title

Sheet no.

Table of Content

AR/00
00

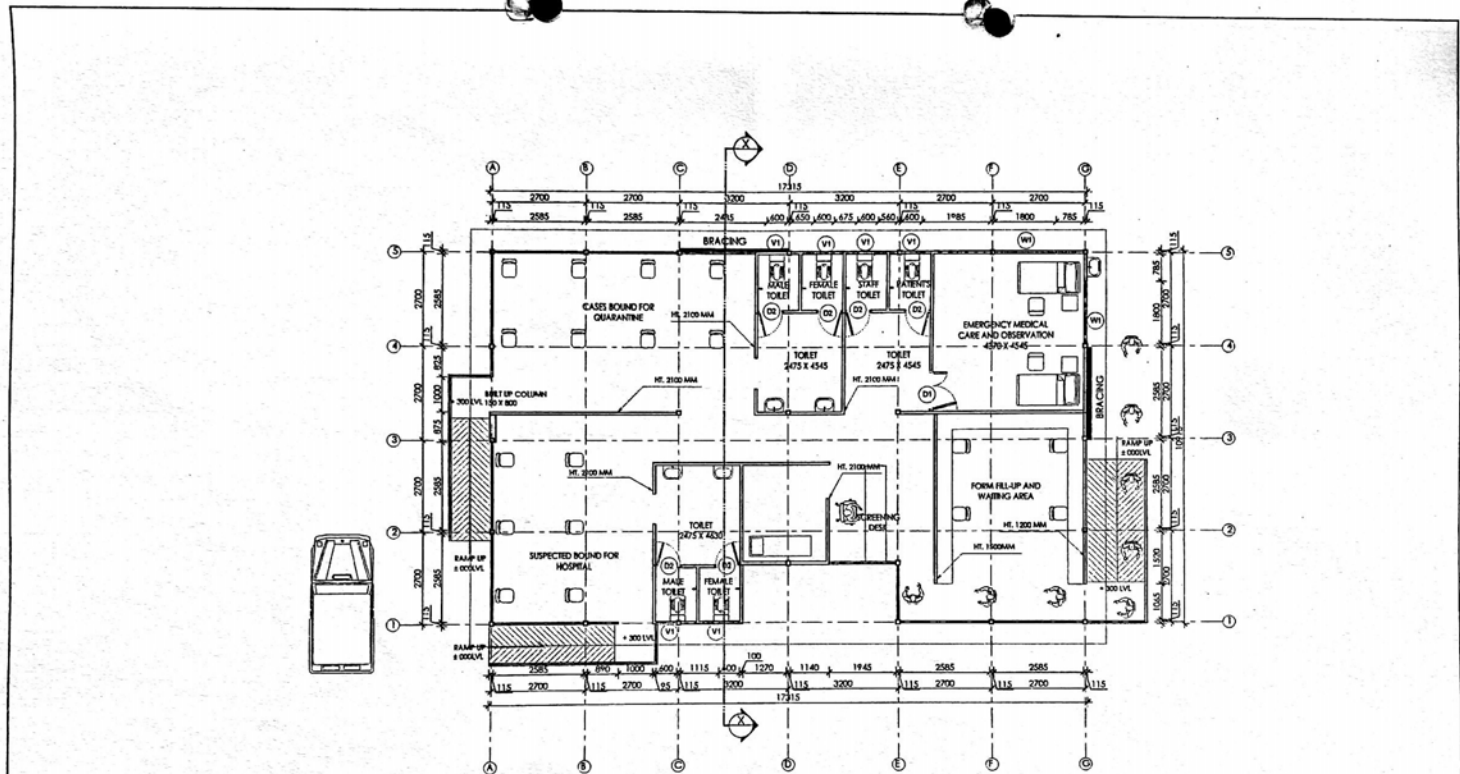


GROUND FLOOR PLAN
Area : 180 SQ. M. (excluding Ramp)

	<p>Ministry of Health & Population RAMSHAHATHI, KATHMANDU</p>		<p>Health Building Infrastructure Standard Design Drawings</p>	<p>Job Name: HEALTH HELP-DESK SCALE: 1:100 DATE: 17/07/2020</p>	<p>Drawing Title Ground floor furniture layout</p>	<p>Sheet no. AR/00 01</p>
--	---	--	--	---	--	-----------------------------------

Handwritten signature and initials

Official stamp of the Ministry of Health & Population, Nepal, dated 17/07/2020.

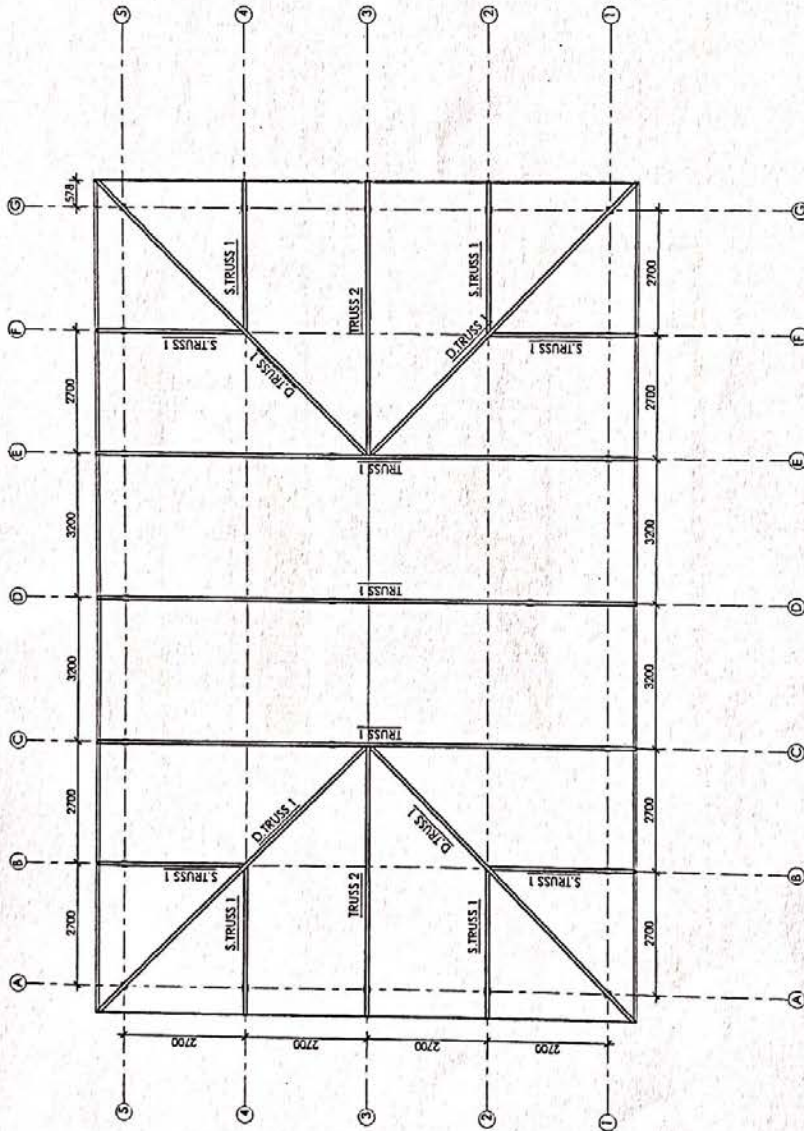

TRUSS LAYOUT PLAN

Sheet no: AR/00/02

Drawing Title: Truss Layout

Job Name: HEALTH HELP DESK
 Scale: 1:100
 Date: 17/07/2019

Health Building Infrastructure
 Standard Design Drawings


NHSSP
 Nepal Health Sector Support Program




Ministry of Health & Population
 PANGNAPATH, KATHMANDU



Handwritten signature and date: 17/07/2019

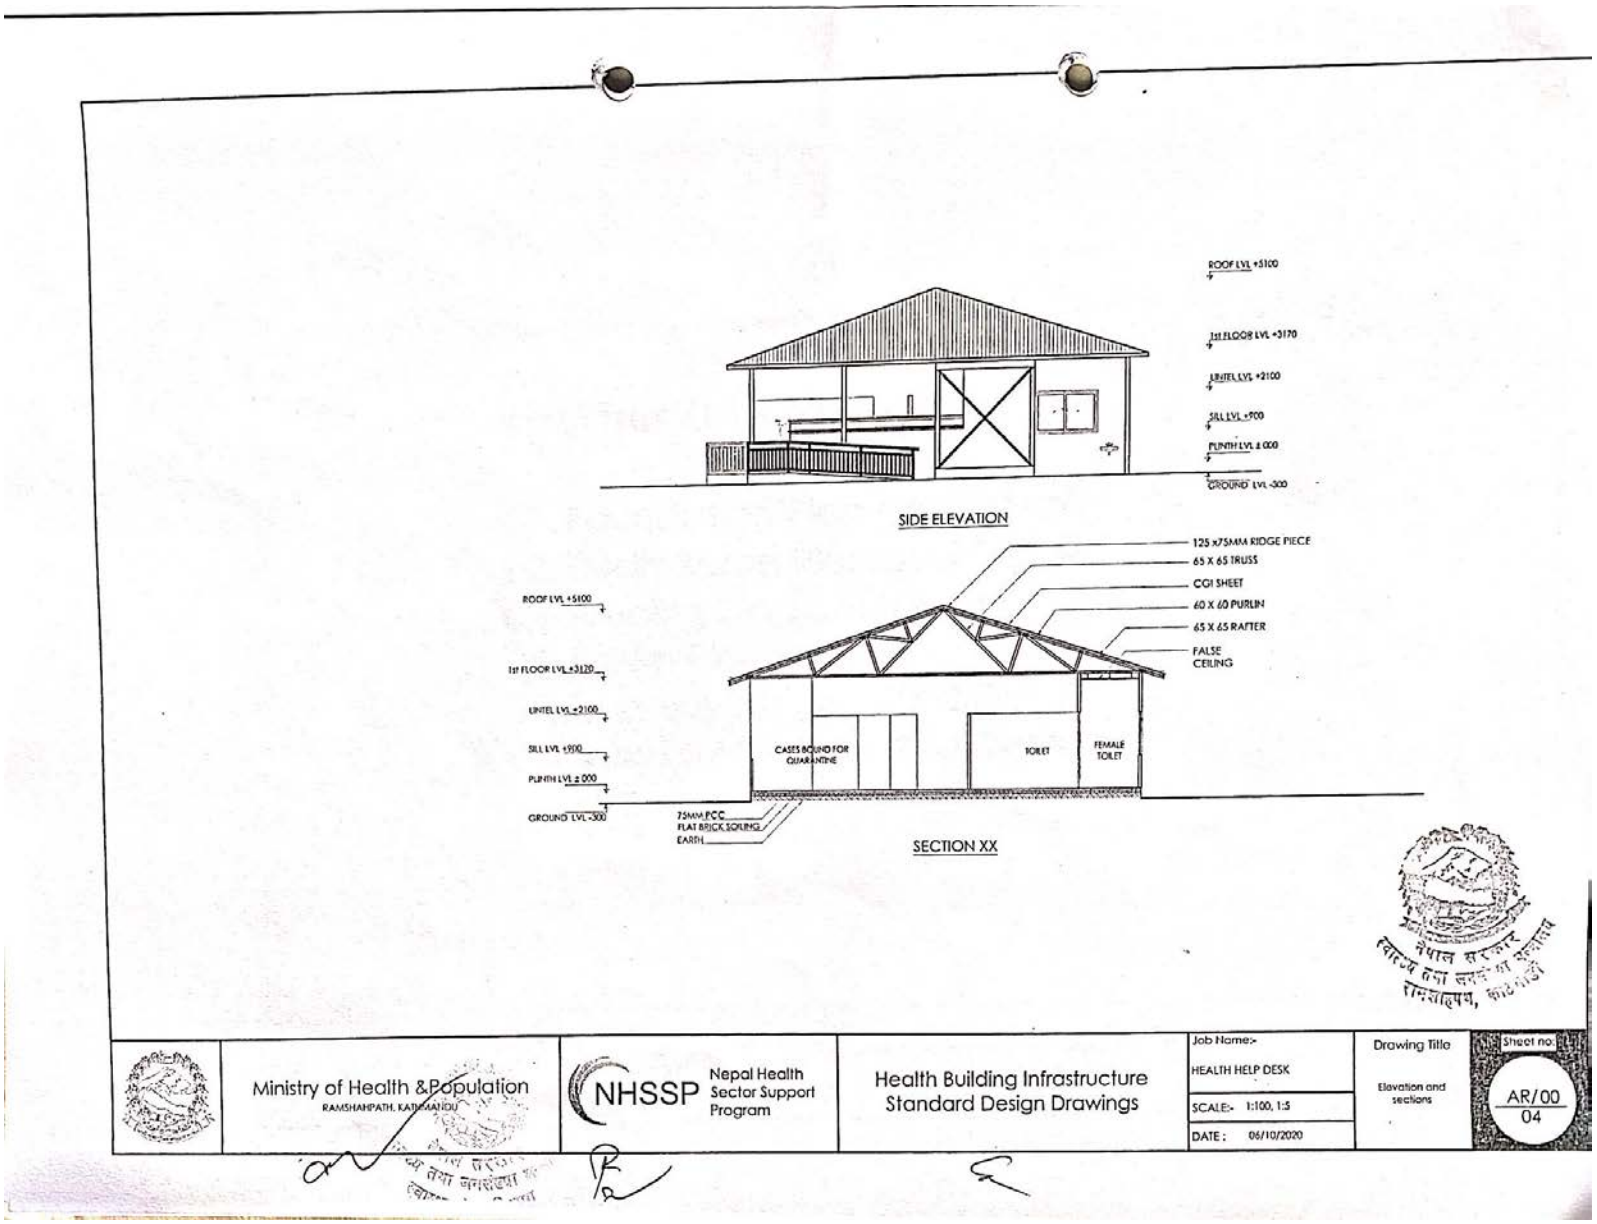Handwritten signature and date: 17/07/2019



 <p>Ministry of Health & Population RAMSHARPAH, KATHMANDU</p>	 <p>NHSSP Nepal Health Sector Support Program</p>	<p>Health Building Infrastructure Standard Design Drawings</p>	Job Name-	<p>Drawing Title Elevation and sections</p>	Sheet no.
			HEALTH HELP DESK		
			SCALE:- 1:100, 1:5		
DATE: 06/10/2020					

Handwritten signatures and stamps in the bottom left corner.

Handwritten signature in the bottom right corner.


STRUCTURAL DRAWINGS

- 01: Foundation Plan and Detail
- 02: Plinth Beam Plan and Detail
- 03: Bracing Plan and Detail
- 04: Beam Plan
- 05: Truss Layout Plan and Detail
- 06: Truss Layout Plan and Detail




	Ministry of Health & Population RAMESHWARPATH, KATHMANDU		Nepal Health Sector Support Program	Health Building Infrastructure Standard Design Drawings	Job Name:- SCREENING CENTERS AT ENTRY POINTS STRUCTURAL DRAWINGS	Drawing Title Table of Content	Sheet no. ST/ 00
					SCALE:-		00
					DATE: 06/10/2020		

Handwritten signatures and stamps in Nepali script.

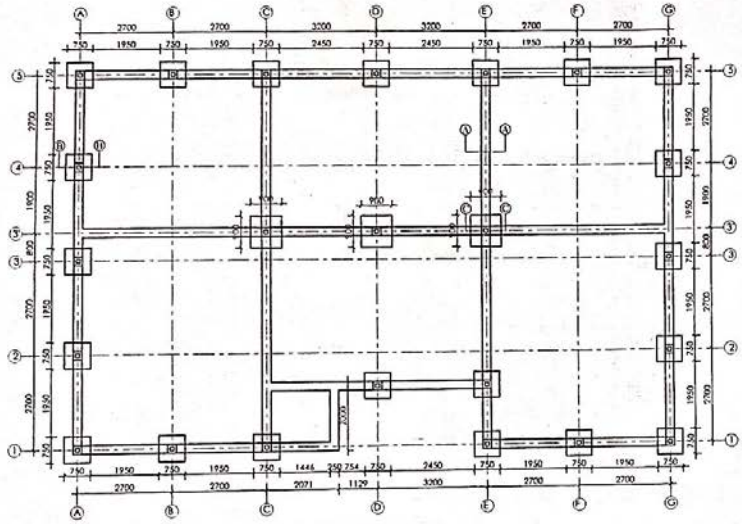

FOUNDATION LAYOUT PLAN

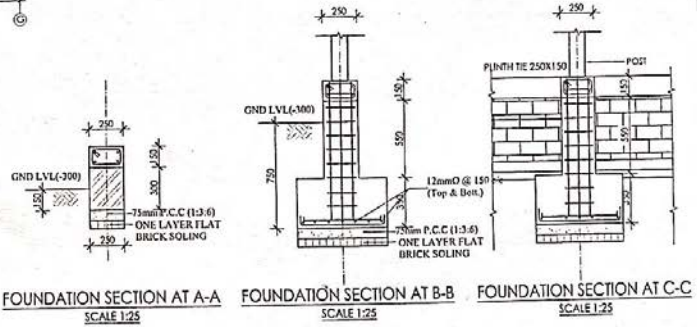


FOUNDATION SECTION AT A-A SCALE 1:25
 FOUNDATION SECTION AT B-B SCALE 1:25
 FOUNDATION SECTION AT C-C SCALE 1:25


Note: Allowable Bearing Capacity of Soil : 150 kN/m² at depth of 0.75m for foundation size 0.5m x 0.5m

	Ministry of Health & Population RAMSHAHPADEI, KATHMANDU		Nepal Health Sector Support Program	Health Building Infrastructure Standard Design Drawings	Job Name:- SCREENING CENTERS AT ENTRY POINTS STRUCTURAL DRAWINGS	Drawing Title Foundation Plan and Detail	Sheet no. ST/ 00 01
					SCALE:- 1:100, 1:25		


Handwritten signatures and stamps at the bottom of the drawing area.

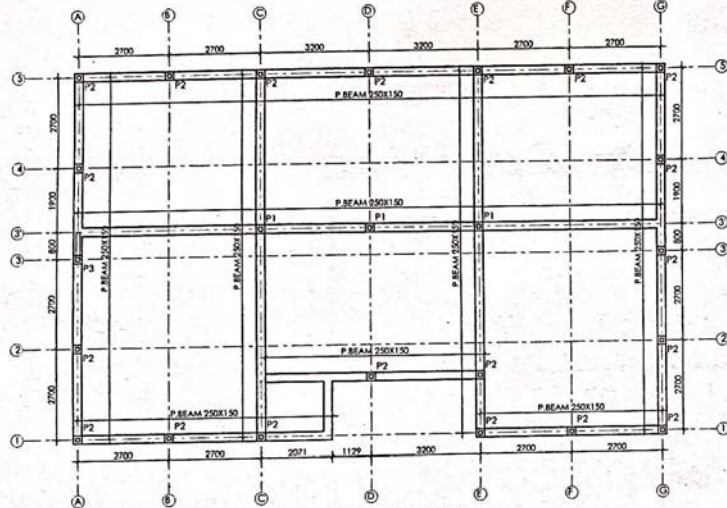


PLINTH BEAM /POST LAYOUT PLAN

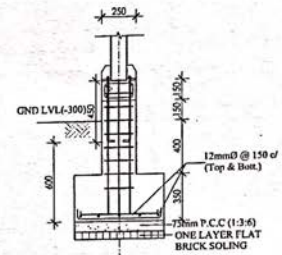


POST/COLUMN CONNECTION DETAILS
SCALE 1:25

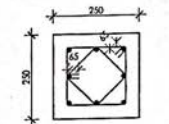


8 NOS. 120
8Ø STIRRUPS @ 150 C-C
CONFINING COLUMN
UP TO PLINTH LEVEL

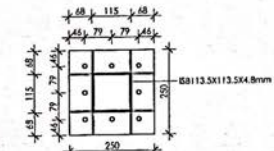

  8 NOS. 120 BOLTS
450mm DEEP
10mm THICK BASE PLATE
BASE PLATE PLAN (P1)






SECTION OF
PLINTH TIE BEAM
SCALE 1:25



TYPICAL PARTITION WALL FOUNDATION
SCALE 1:25




 <p>Ministry of Health & Population RAMSHANPATH, KATHMANDU</p>	 <p>Nepal Health Sector Support Program</p>	Job Name:- SCREENING CENTERS AT ENTRY POINTS STRUCTURAL DRAWINGS	Drawing Title Plinth Beam Plan and Detail	Sheet no. ST/ 00 02
		SCALE:- 1:100, 1:25	DATE: 06/10/2020	

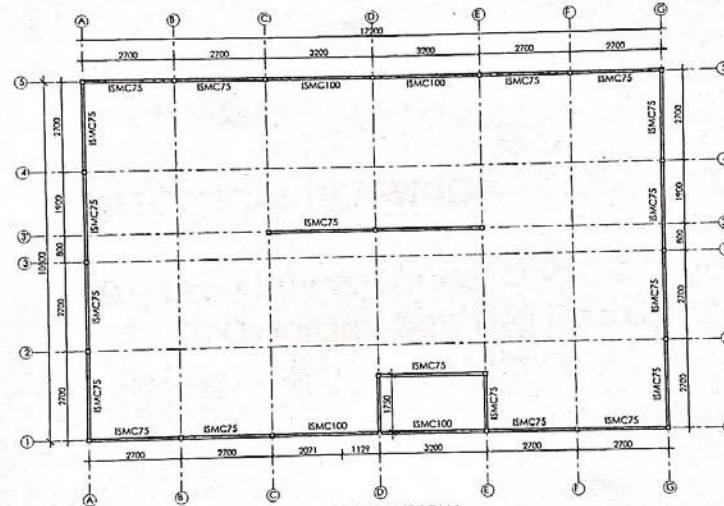

EAVES LEVEL TIE BEAM
LAYOUT PLAN



 Ministry of Health & Population
RAMSHAH PATHI, KATHMANDU



NHSSP
Nepal Health Sector Support Program

Health Building Infrastructure
Standard Design Drawings

Job Name:-
SCREENING CENTERS AT ENTRY POINTS
STRUCTURAL DRAWINGS
SCALE:- 1:100
DATE: 06/10/2020

Drawing Title
beam Plan

Sheet no.
ST/ 00
04

 
Handwritten signatures and initials in blue ink.

ELECTRICAL DRAWINGS

- 01: Light Power Socket and DB Layout
- 02: DB Diagram, Earthing Detail, IP Network Detail
- 03: Instruction and Legends



Ministry of Health & Population
RAMSHAHIPATH, KATHMANDU



Nepal Health
Sector Support
Program


Health Building Infrastructure
Standard Design Drawings

Job Name:-
SCREENING CENTERS AT ENTRY POINTS
ELECTRICAL DRAWINGS
SCALE:-
DATE: 06/10/2020

Drawing Title
Table of Content

Sheet no.
EL/ 00
00

[Handwritten signatures and stamps]

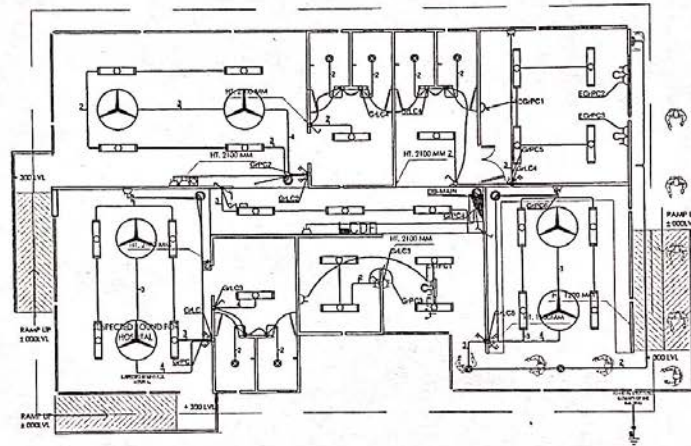

LEGEND

SYMBOL	DESCRIPTION	QUANTITY	UNIT
[Symbol]	10 W SURFACE RECESSED LED PANEL	10	NO
[Symbol]	20 W SURFACE RECESSED LED PANEL	10	NO
[Symbol]	30 W SURFACE RECESSED LED PANEL	10	NO
[Symbol]	1000 W SURFACE RECESSED LED PANEL	10	NO



Ministry of Health & Population
RAMSHAHPATH, KATHMANDU



NHSSP
Nepal Health Sector Support Program

Health Building Infrastructure
Standard Design Drawings


Job Name:-
SCREENING CENTERS AT ENTRY POINTS
ELECTRICAL DRAWINGS
SCALE:-
DATE: 06/10/2020

Drawing Title
Light, Power Socket
and DB Layout


Sheet no
EL/ 00
01


 
Handwritten signatures and initials in Nepali script.

Handwritten signature.

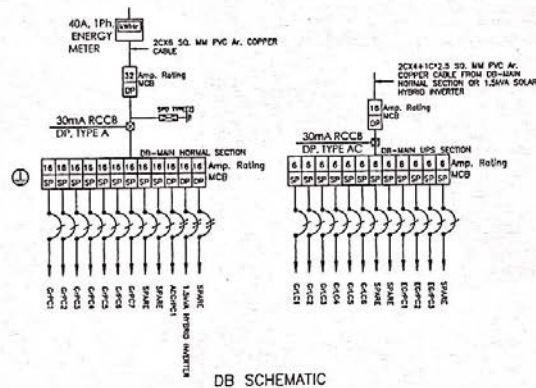

DB SCHEMATIC

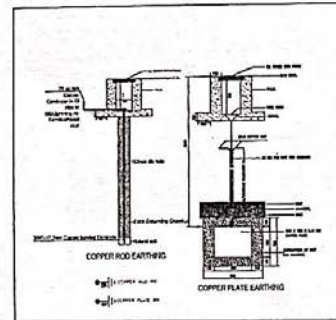



 <p>Ministry of Health & Population RAMSHAHPATH, KATHMANDU</p>	 <p>NHSSP Nepal Health Sector Support Program</p>	<p>Health Building Infrastructure Standard Design Drawings</p>	<p>JOB No: -</p> <p>SCREENING CENTERS AT ENTRY POINTS ELECTRICAL DRAWINGS</p>	<p>Drawing Title</p> <p>DB Diagram, Earthing Detail, IP Network Detail</p>	<p>Sheet no.</p> <p>EL/ 00 02</p>
			<p>SCALE:-</p> <p>DATE: 06/10/2020</p>		


SANITARY DRAWINGS

- 01: Water Supply Layout Plan
- 02: Sanitary Layout Plan



 Ministry of Health & Population RAMSHAHIPATH, KATHMANDU	 Nepal Health Sector Support Program	Health Building Infrastructure Standard Design Drawings	Job Name-> HEALTH HELP DESK	Drawing Title	Sheet no
			SCALE->	Table of Content	SA/00 00
			DATE: 06/10/2020		

Handwritten signatures and initials:
[Signature] [Initials] [Initials]

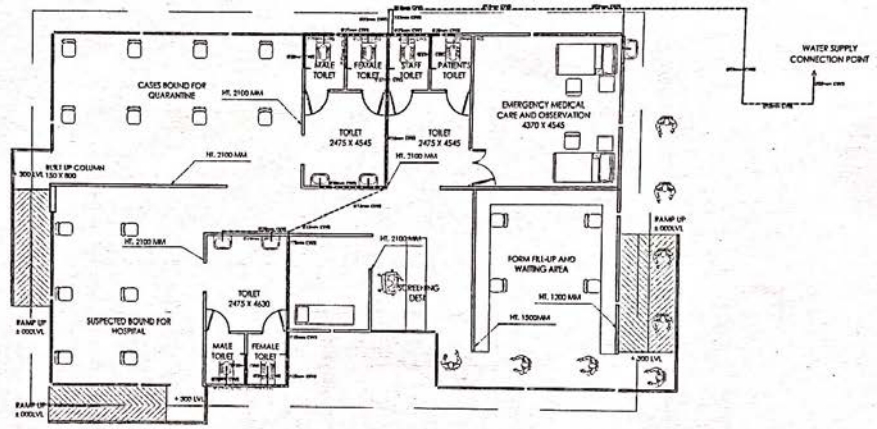


WATER SUPPLY LAYOUT PLAN



	<p>Ministry of Health & Population RAMSHAPATH, KATHMANDU</p>	<p>NHSSP Nepal Health Sector Support Program</p>	<p>Health Building Infrastructure Standard Design Drawings</p>	<p>Job Name:- SCREENING CENTERS AT ENTRY POINTS SANITARY DRAWINGS SCALE:- 1:100 DATE: 14/10/2020</p>	<p>Drawing Title Water Supply Layout Plan</p>	<p>Sheet no SA/00 01</p>
--	--	--	--	--	---	----------------------------------

Handwritten signatures and initials in blue ink, including a large 'R' and 'Q'.

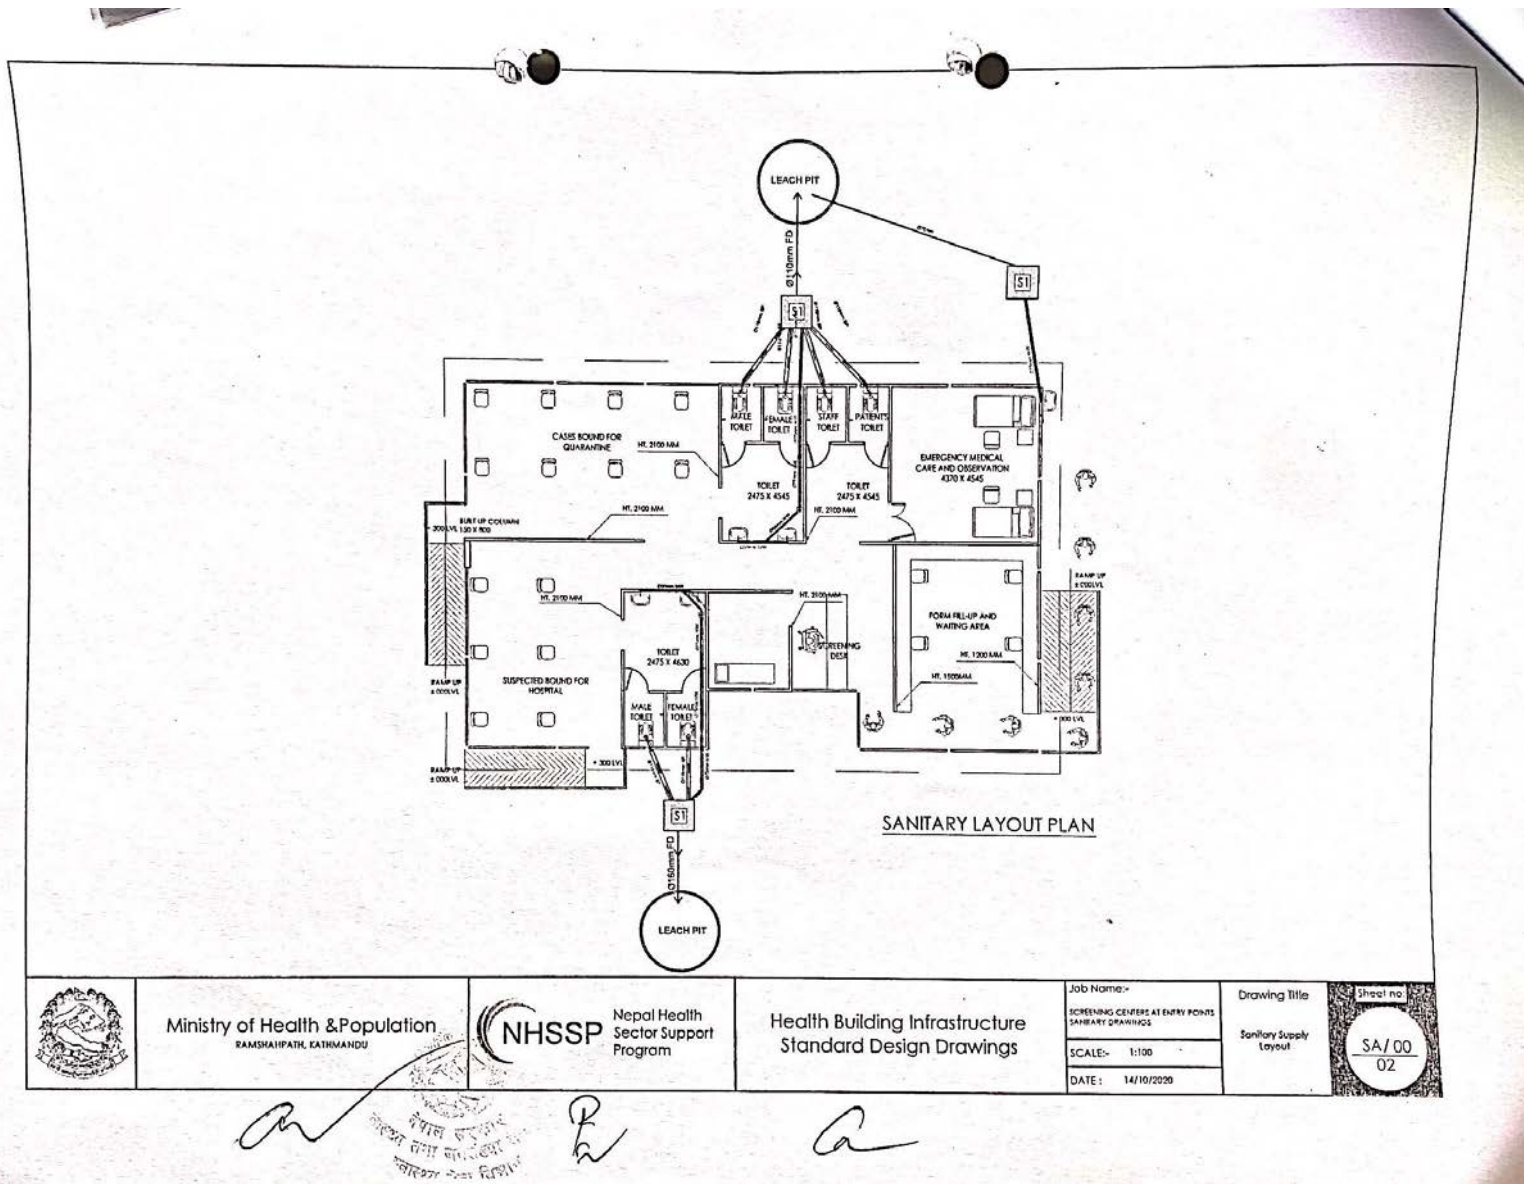

Ministry of Health & Population
RAMSHAI PATH, KATHMANDU

NHSSP Nepal Health Sector Support Program

Health Building Infrastructure
Standard Design Drawings

Job Name:-
SCREENING CENTERS AT ENTRY POINTS
SANITARY DRAWINGS
SCALE:- 1:100
DATE: 14/10/2020

Drawing Title
Sanitary Supply
Layout

Sheet no.
SA/00
02

Handwritten signatures and stamps:
A large signature on the left, a circular official stamp in the center, and another signature on the right.